


DATE: _____
SCALE: 1/16"=1'-0"
DRAWN BY: _____
PROJECT: _____

REVISIONS:


EBM II
FARMINGTON INDUSTRIAL PARK
HYDE ROAD
FARMINGTON CONNECTICUT

WAREHOUSE HVAC FLOOR PLAN

NOT TO SCALE

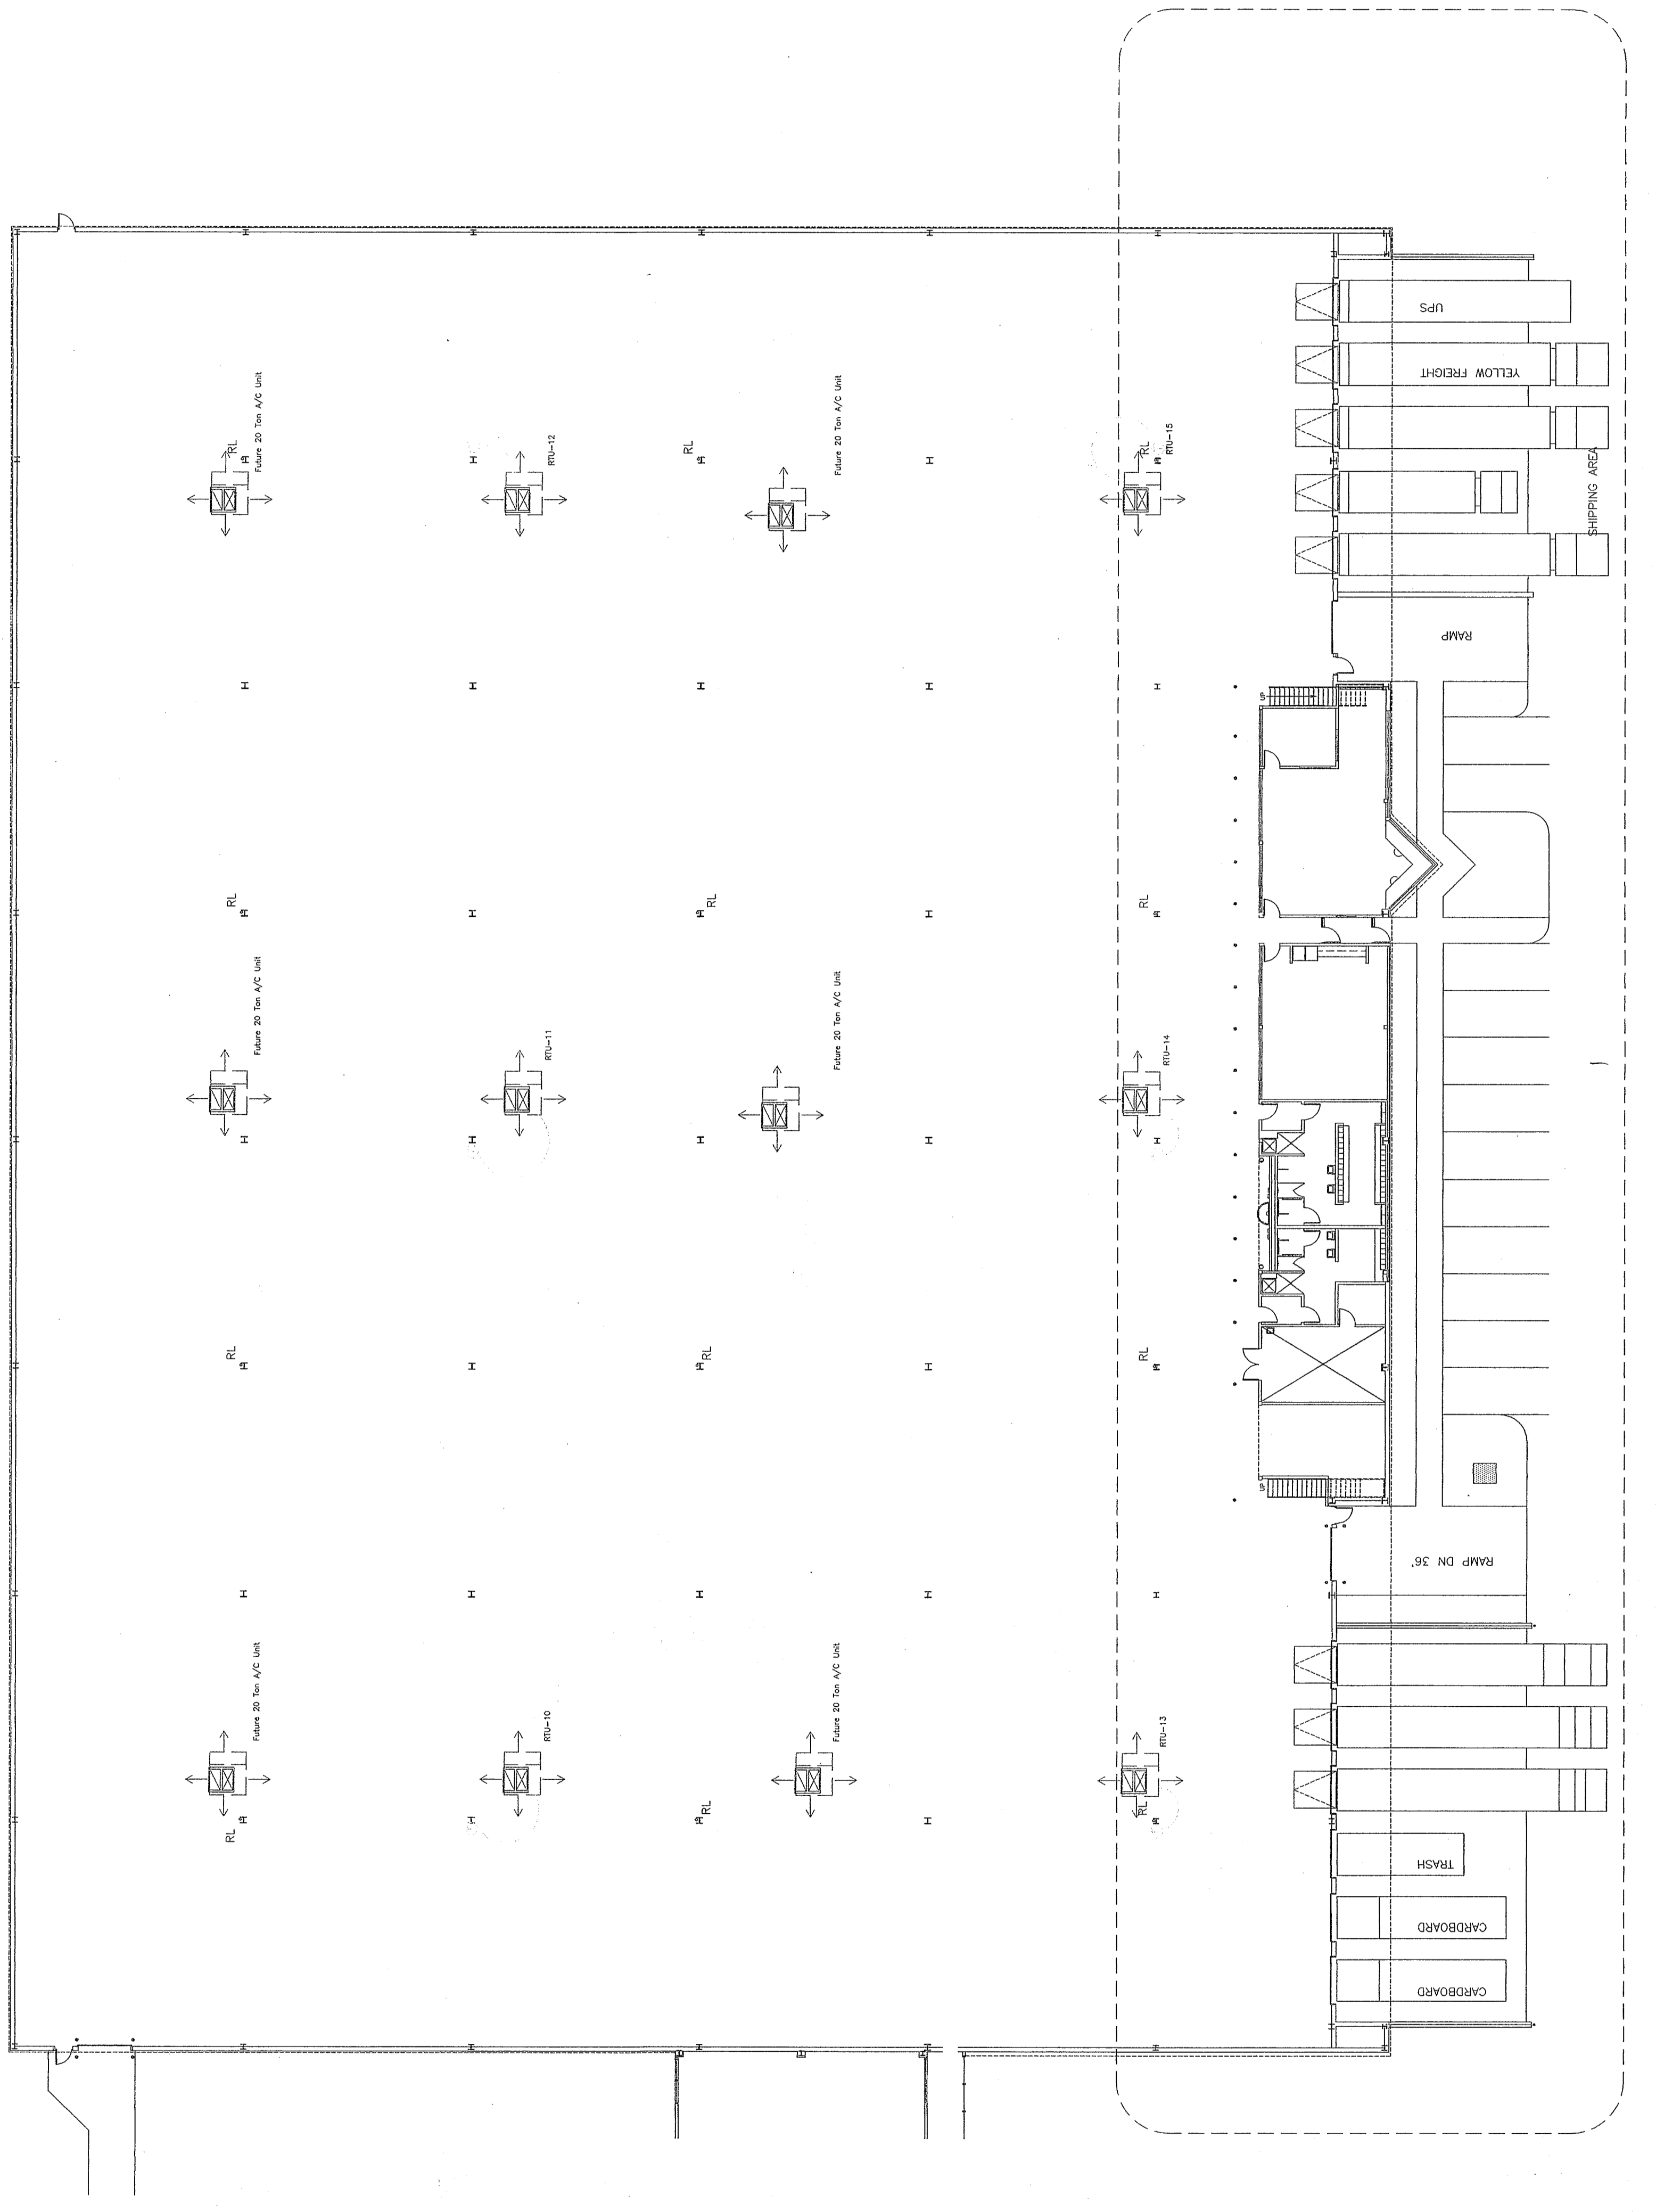

① ENLARGED PARTIAL PLAN
SCALE 1/8"=1'-0"

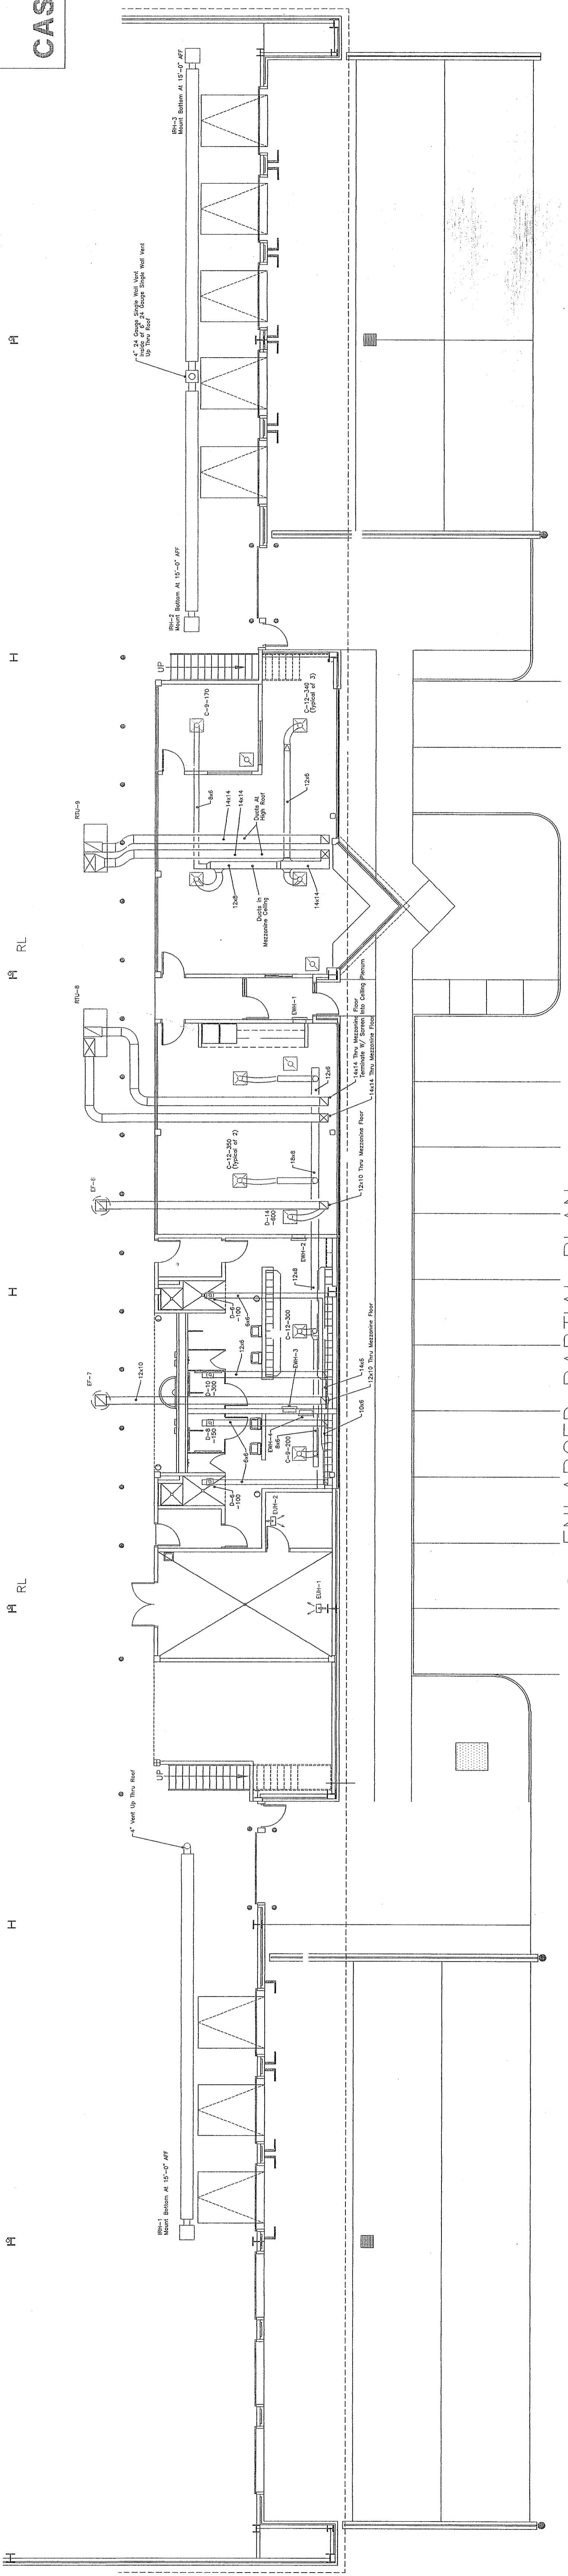

CASLE